



SECOND FLOOR PLAN



FIRST FLOOR PLAN

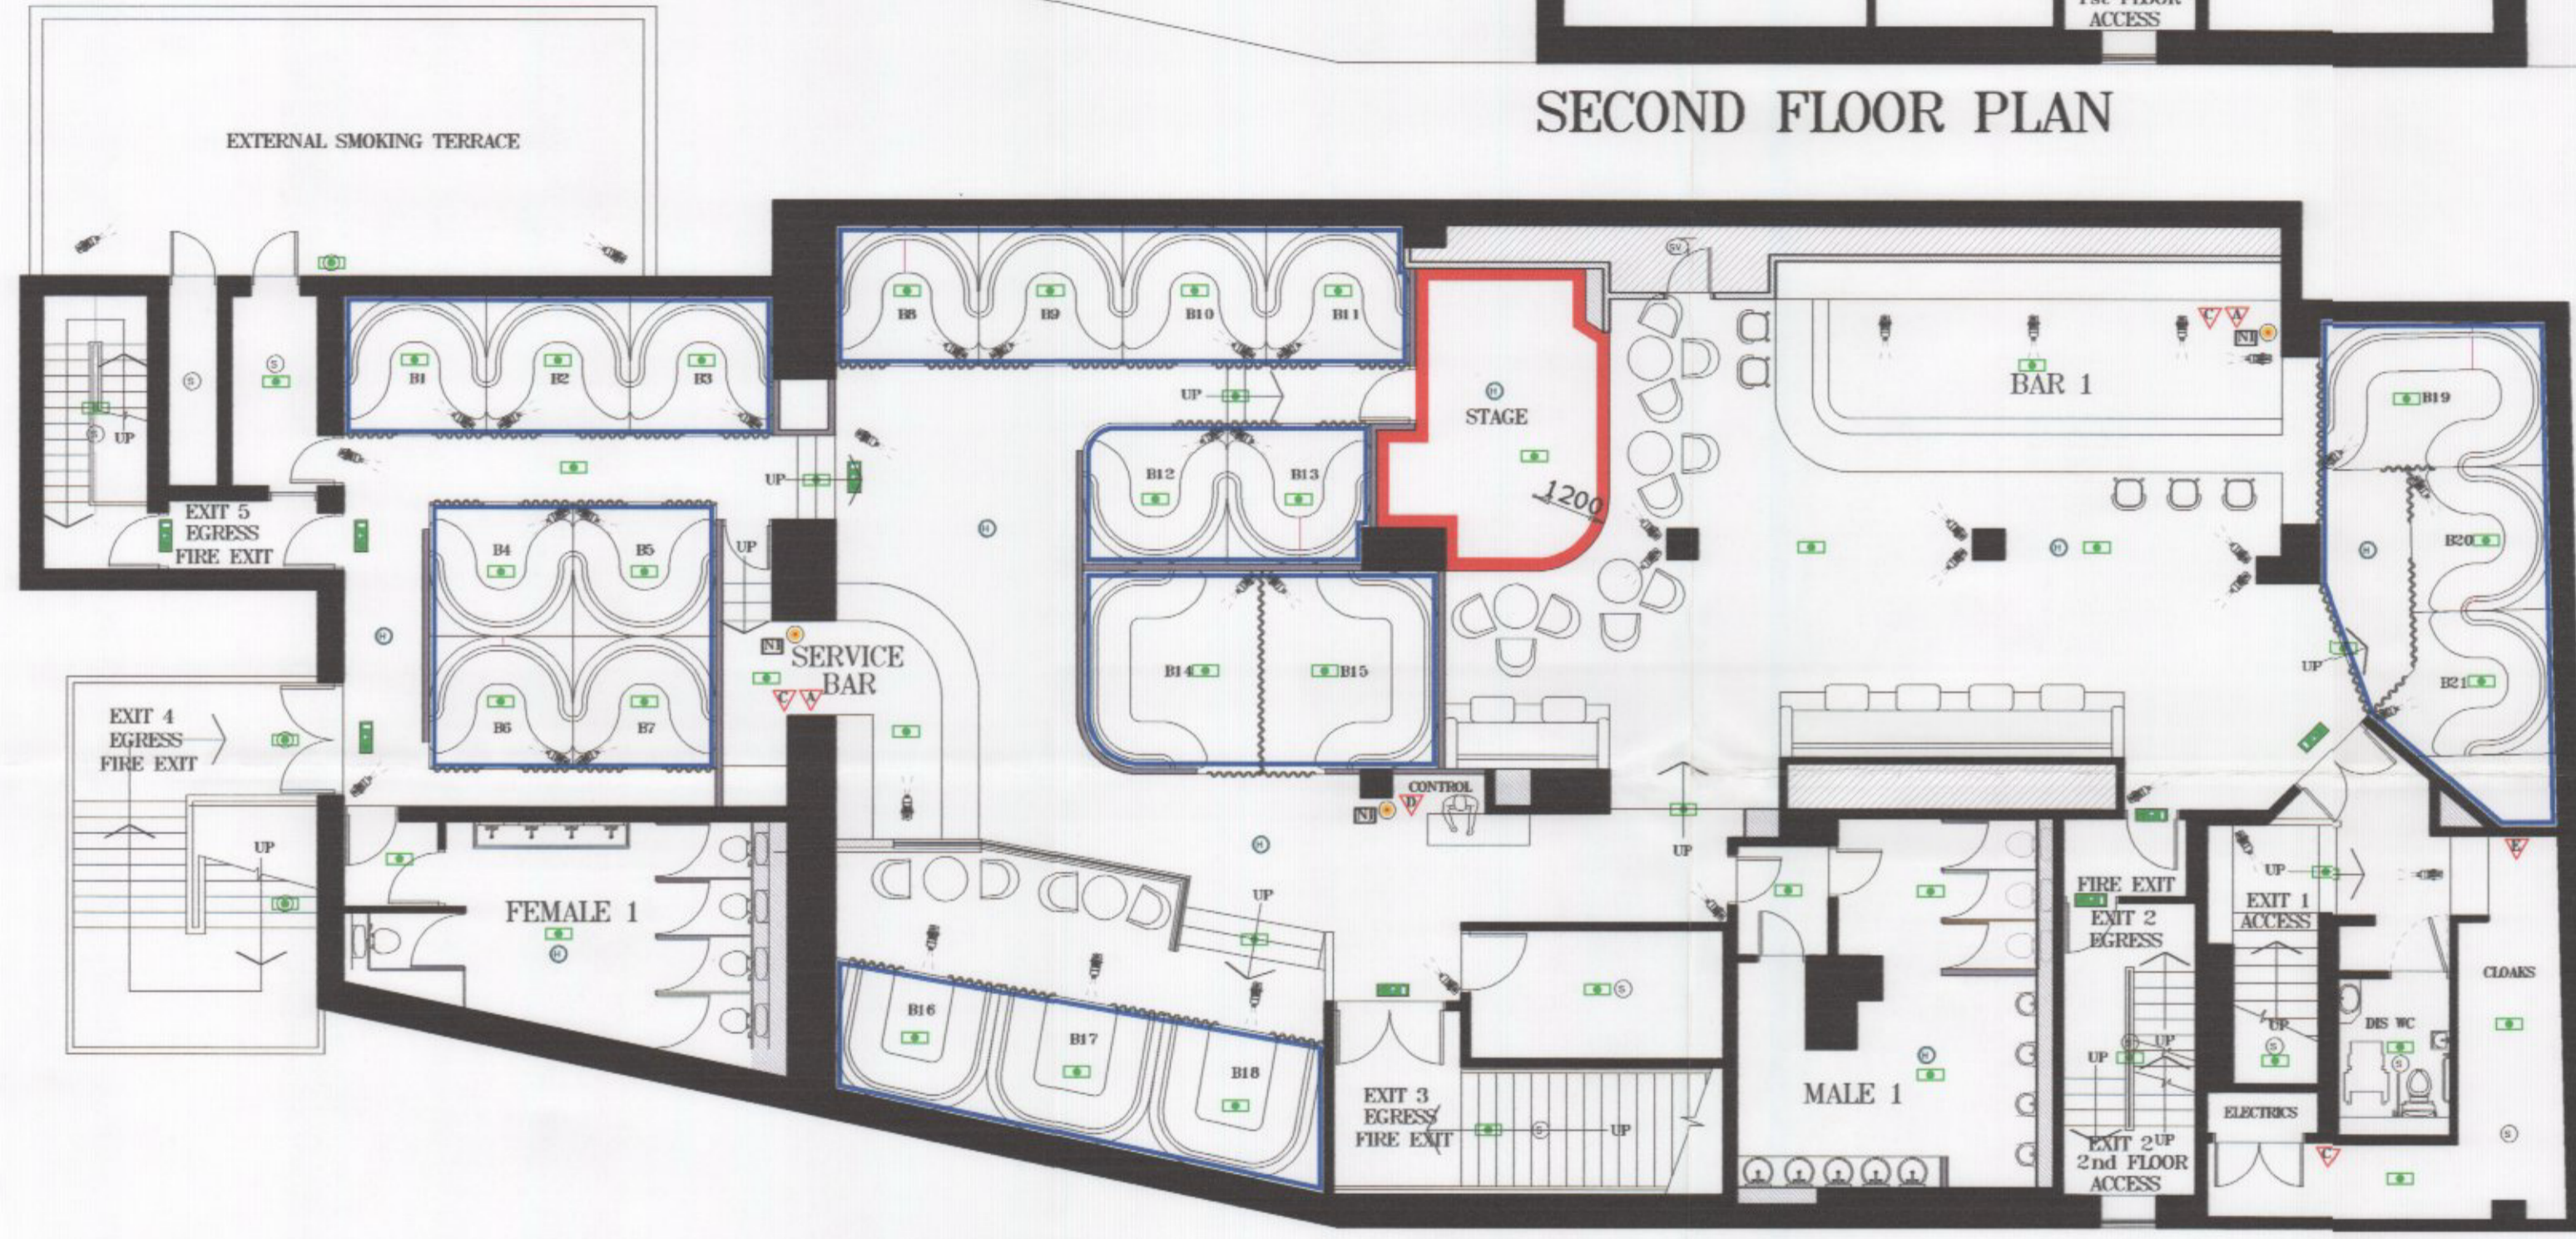

FRONT ELEVATION

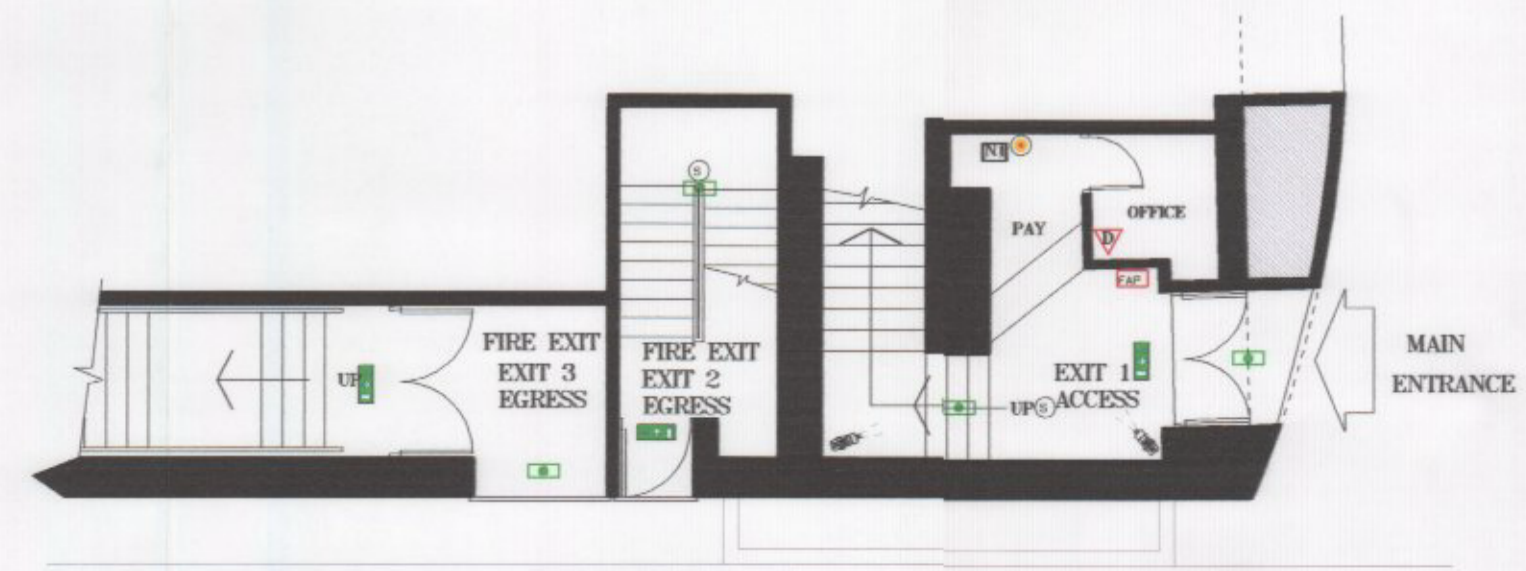

GROUND FLOOR PLAN

- FIRE ALARM**
- ⊙ VOID DETECTOR
 - ⊙ REDCARE LINE
 - ⊙ SMOKE DETECTOR
 - ⊙ SMOKE DETECTOR / FIRST STAGE SOUNDER
 - ⊙ HEAT DETECTOR
 - ⊙ HEAT DETECTOR / FIRST STAGE SOUNDER
 - ⊙ COMBINE SMOKE & HEAT DETECTOR
 - ⊙ MANUAL CALL POINT
 - ⊙ FIRST STAGE SOUNDER-LED
 - ⊙ FIRST STAGE SOUNDER-NEON
 - ⊙ VOICE EVACUATION SOUNDER
 - ⊙ VOICE EVACUATION PROJECTION SOUNDER
 - ⊙ FLASHING BEACON
 - ⊙ INTERFACE
 - ⊙ FIRE ALARM PANEL
 - ⊙ FIRE ALARM REPEATER PANEL
 - ⊙ DISABLE REFUGE INTERCOM POINT
- EMERGENCY LIGHTING**
- ⊙ EMERGENCY LIGHT 240V N/M3 BULKHEAD LIGHT BOH
 - ⊙ PUBLIC AREA COMBINE 28 WATT 2D DECORATIVE FITTING
 - ⊙ EMERGENCY SIGN 240V M3
 - ⊙ BOH REF AC5004 PUBLIC AREA AC5019
 - ⊙ EMERGENCY / CLEANERS LIGHT 240V N/M3 IP20 TWIN SPOT WITH MULTI DIRECTIONAL HEADS REF AC5007
- FIRE EQUIPMENT**
- ⊙ 6kg MULTI-PURPOSE FOAM EXTINGUISHER
 - ⊙ FIRE BLANKET
 - ⊙ 2kg CARBON DIOXIDE EXTINGUISHER
 - ⊙ AQUARIUS FOAM FILLED
 - ⊙ 6ltr MULTI PURPOSE WATER EXTINGUISHER
 - ⊙ DRY POWDER
- FIRE NOTICES**
- ⊙ GENERAL BY EACH CALL POINT
 - ⊙ STAFF
 - ⊙ KITCHEN
 - ⊙ DUTY MANAGER

AREA BOUNDED BY THE RED LINE INDICATES THE AREA WHERE PERFORMANCES TAKE PLACE

AREA BOUNDED BY THE BLUE LINE INDICATES THE AREA WHERE PRIVATE SCREENED PERFORMANCES TAKE PLACE

⊙ CCTV CAMERAS

Easy Design Solutions
EDS Studio 48
 Bachelor Road
 Harrogate
 HG1 3EQ
 grt@easy-designs.co.uk
 mob: 07903730044

Client _____
 Project FEVER BARS
 YOOODOO CHELTENHAM GL53 7HB
 Title PROPOSED LAP DANCING CLUB
 Drawn by GRT Date SEPT-13
 Scale 1:100 @ A2
 Directory FEVER GROUP
 Drawing no YOOODOO
 Proj Lib FEVERGROUP
 Layerwt _____

VD-13-102