



SECOND FLOOR PLAN

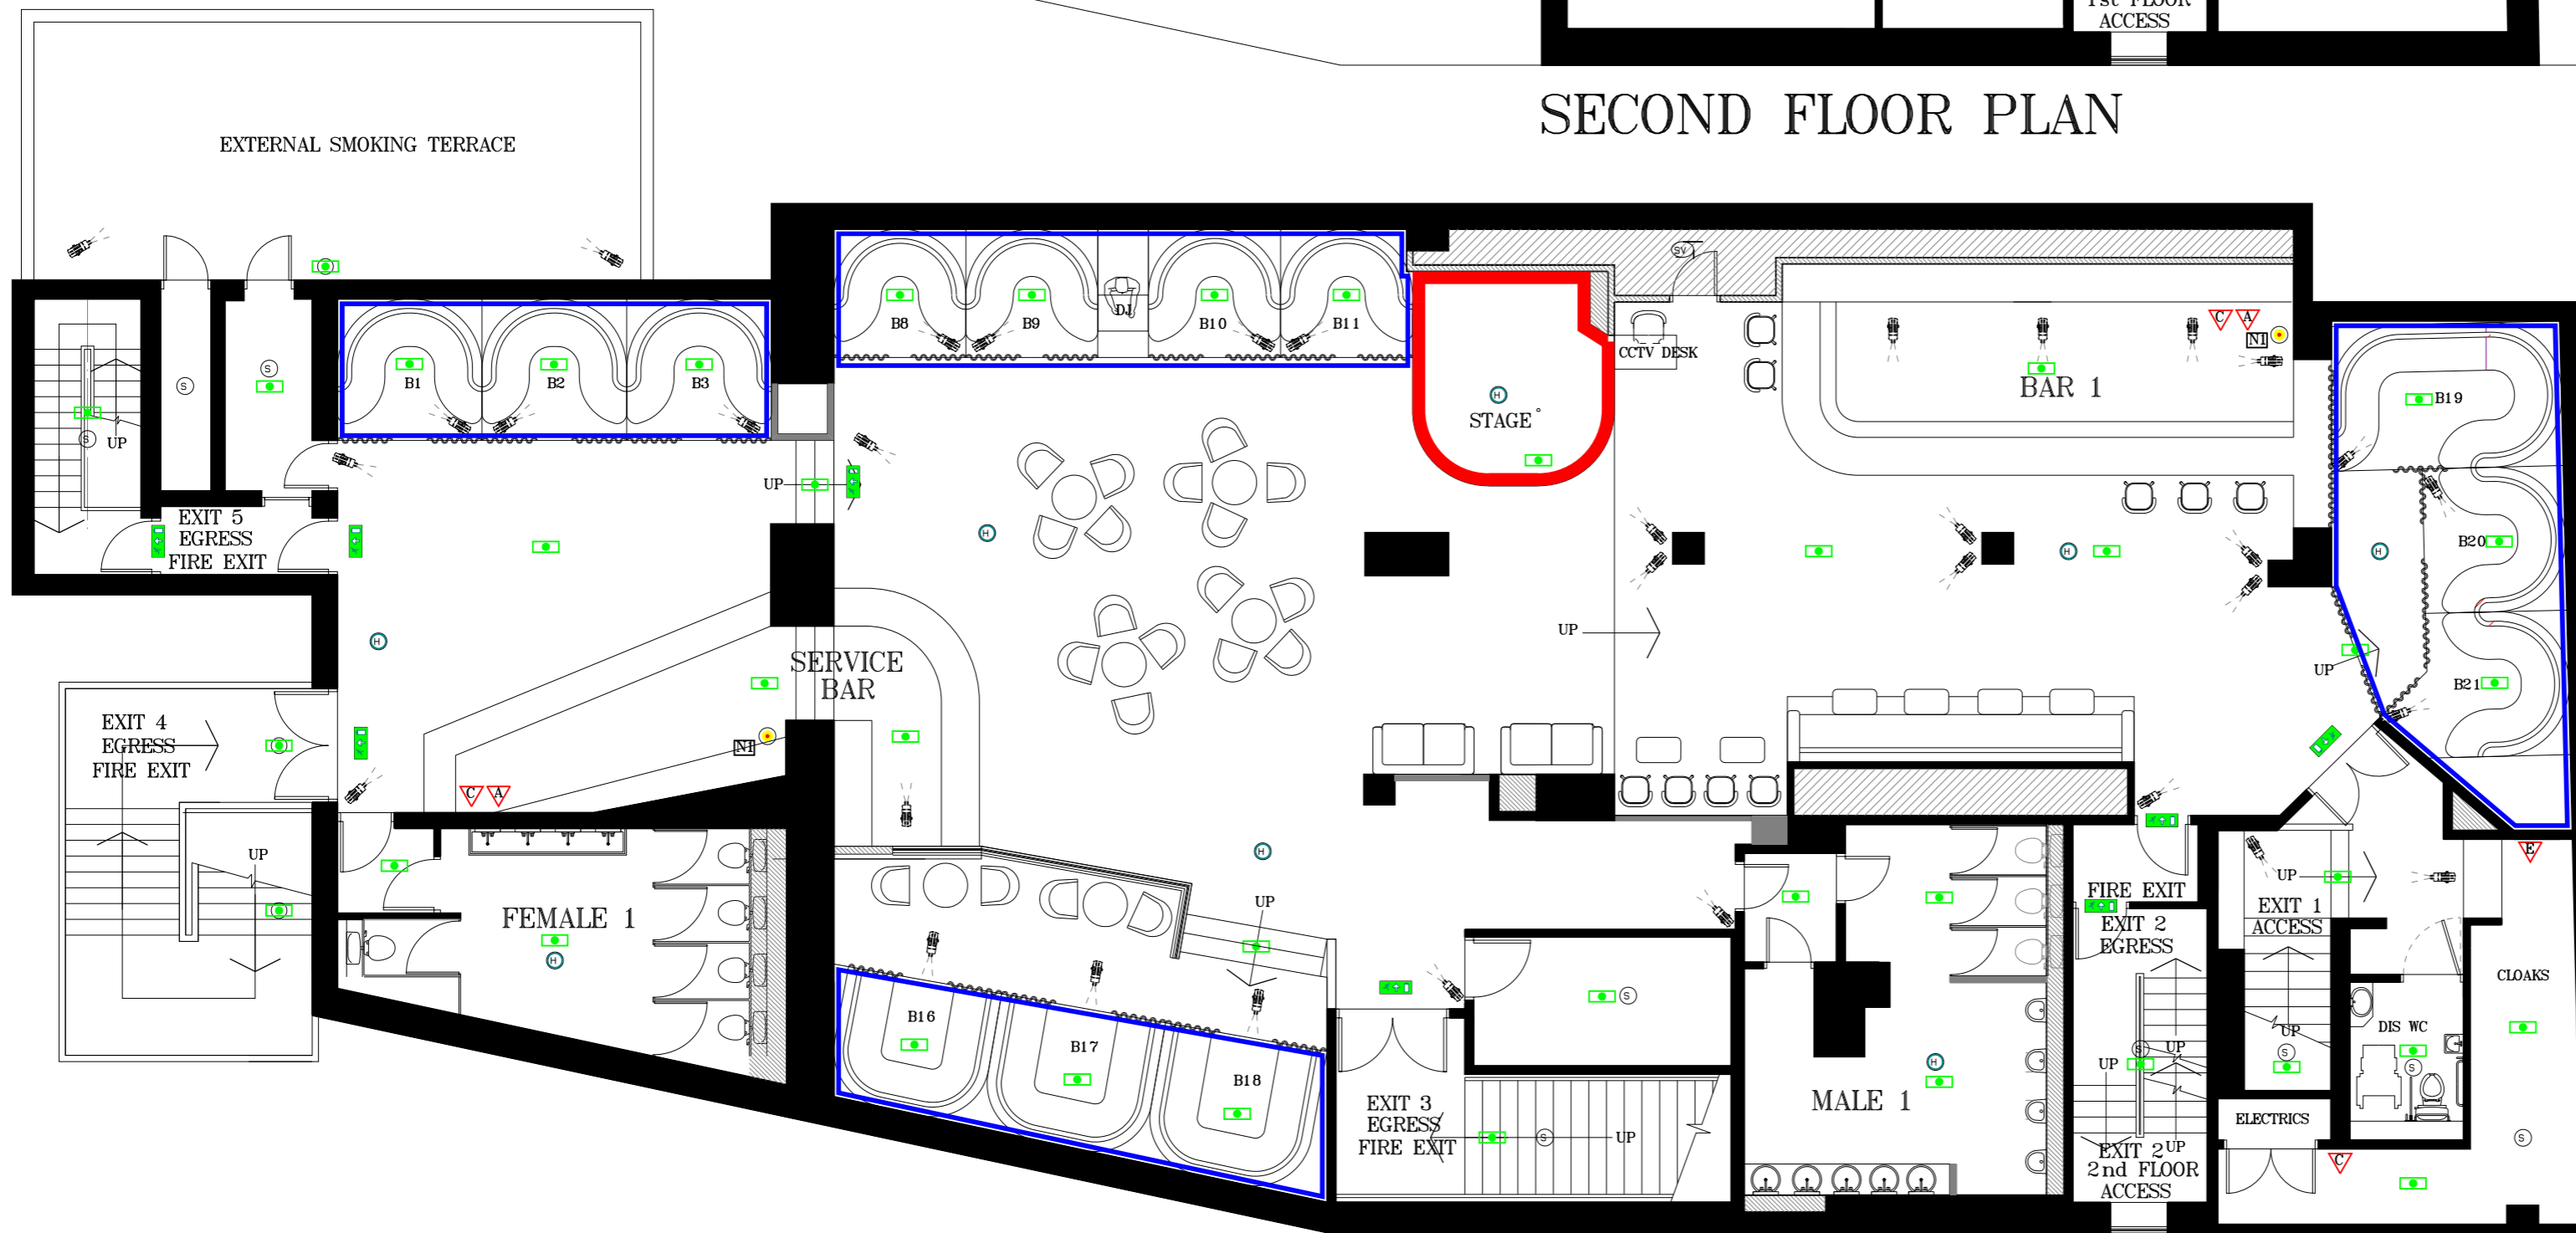

FIRST FLOOR PLAN





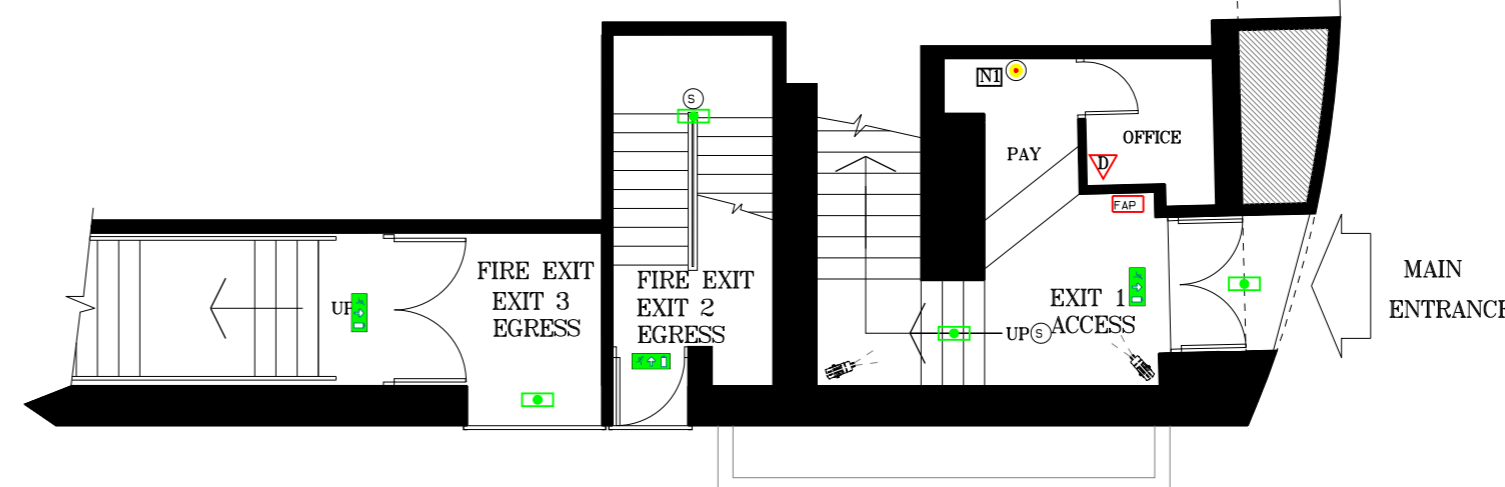FRONT ELEVATION



GROUND FLOOR PLAN

- FIRE ALARM**
- VD VOID DETECTOR
 - RL REDCARE LINE
 - SD SMOKE DETECTOR
 - SS SMOKE DETECTOR / FIRST STAGE SOUNDER
 - HT HEAT DETECTOR
 - HS HEAT DETECTOR / FIRST STAGE SOUNDER
 - CS COMBINE SMOKE & HEAT DETECTOR
 - MC MANUAL CALL POINT
 - FS FIRST STAGE SOUNDER-LED
 - FN FIRST STAGE SOUNDER-NEON
 - VE VOICE EVACUATION SOUNDER
 - VPS VOICE EVACUATION PROJECTION SOUNDER
 - FB FLASHING BEACON
 - INT INTERFACE
 - FAP FIRE ALARM PANEL
 - FARP FIRE ALARM REPEATER PANEL
 - DRP DISABLE REFUGE INTERCOM POINT
- EMERGENCY LIGHTING**
- EL EMERGENCY LIGHT 240V N/M3 BULKHEAD LIGHT BOH
 - ELC PUBLIC AREA COMBINE 28 WATT 2D DECORATIVE FITTING
 - ES EMERGENCY SIGN 240V M3
 - ELB BOH REF AC5004 PUBLIC AREA AC5019
 - ELC2 EMERGENCY / CLEANERS LIGHT 240V N/M3 IP20 TWIN SPOT WITH MULTI DIRECTIONAL HEADS REF AC5007
- FIRE EQUIPMENT**
- 6kg MPF 6kg MULTI-PURPOSE FOAM EXTINGUISHER
 - FB FIRE BLANKET
 - 2kg CD 2kg CARBON DIOXIDE EXTINGUISHER
 - AFF AQUARIUS FOAM FILLED
 - 6ltr MPW 6ltr MULTI PURPOSE WATER EXTINGUISHER
 - DP DRY POWDER
- FIRE NOTICES**
- NI GENERAL BY EACH CALL POINT
 - ST STAFF
 - KI KITCHEN
 - DM DUTY MANAGER
 - CCV CCTV CAMERAS

 AREA BOUNDED BY THE RED LINE INDICATES THE AREA WHERE PERFORMANCES TAKE PLACE

 AREA BOUNDED BY THE BLUE LINE INDICATES THE AREA WHERE PRIVATE SCREENED PERFORMANCES TAKE PLACE

Easy Design Solutions
EDS Studio 48
 Bachelor Road
 Harrogate
 HG1 3EQ
 grt@easy-designs.co.uk
 mob: 07903730044

Client FANTASY CLUBS
 Project FANTASY CHELTENHAM GL53 7HB
 Title EXISTING & PROPOSED PLANS
 Drawn by GRT Date DEC-14
 Directory FEVER GROUP Scale 1:100 @ A2
 Drawing no. FANT-CH-
 Proj Lib FEVERGROUP
 Layerset FB-14-103